

ELECTRICAL LEGEND

	FUSE BOX
	ELECTRICAL INLET
	SOCKET
	DOUBLE SWITCH
	60X60 LIGHTING FIXTURES
	AIR CONDITIONER



Kibbutz Mishmarot 37840 Doar Na Menashe Israel
 Tel: 04-6277786
 www.con-modular.co.il

client:
 -

project:
 TYPE A 18.0 m²


revision:

no	description	date
1.	-	-
2.	-	-
3.	-	-

drawn by: -

date: 26.12.2019

all dimensions are in centimeters

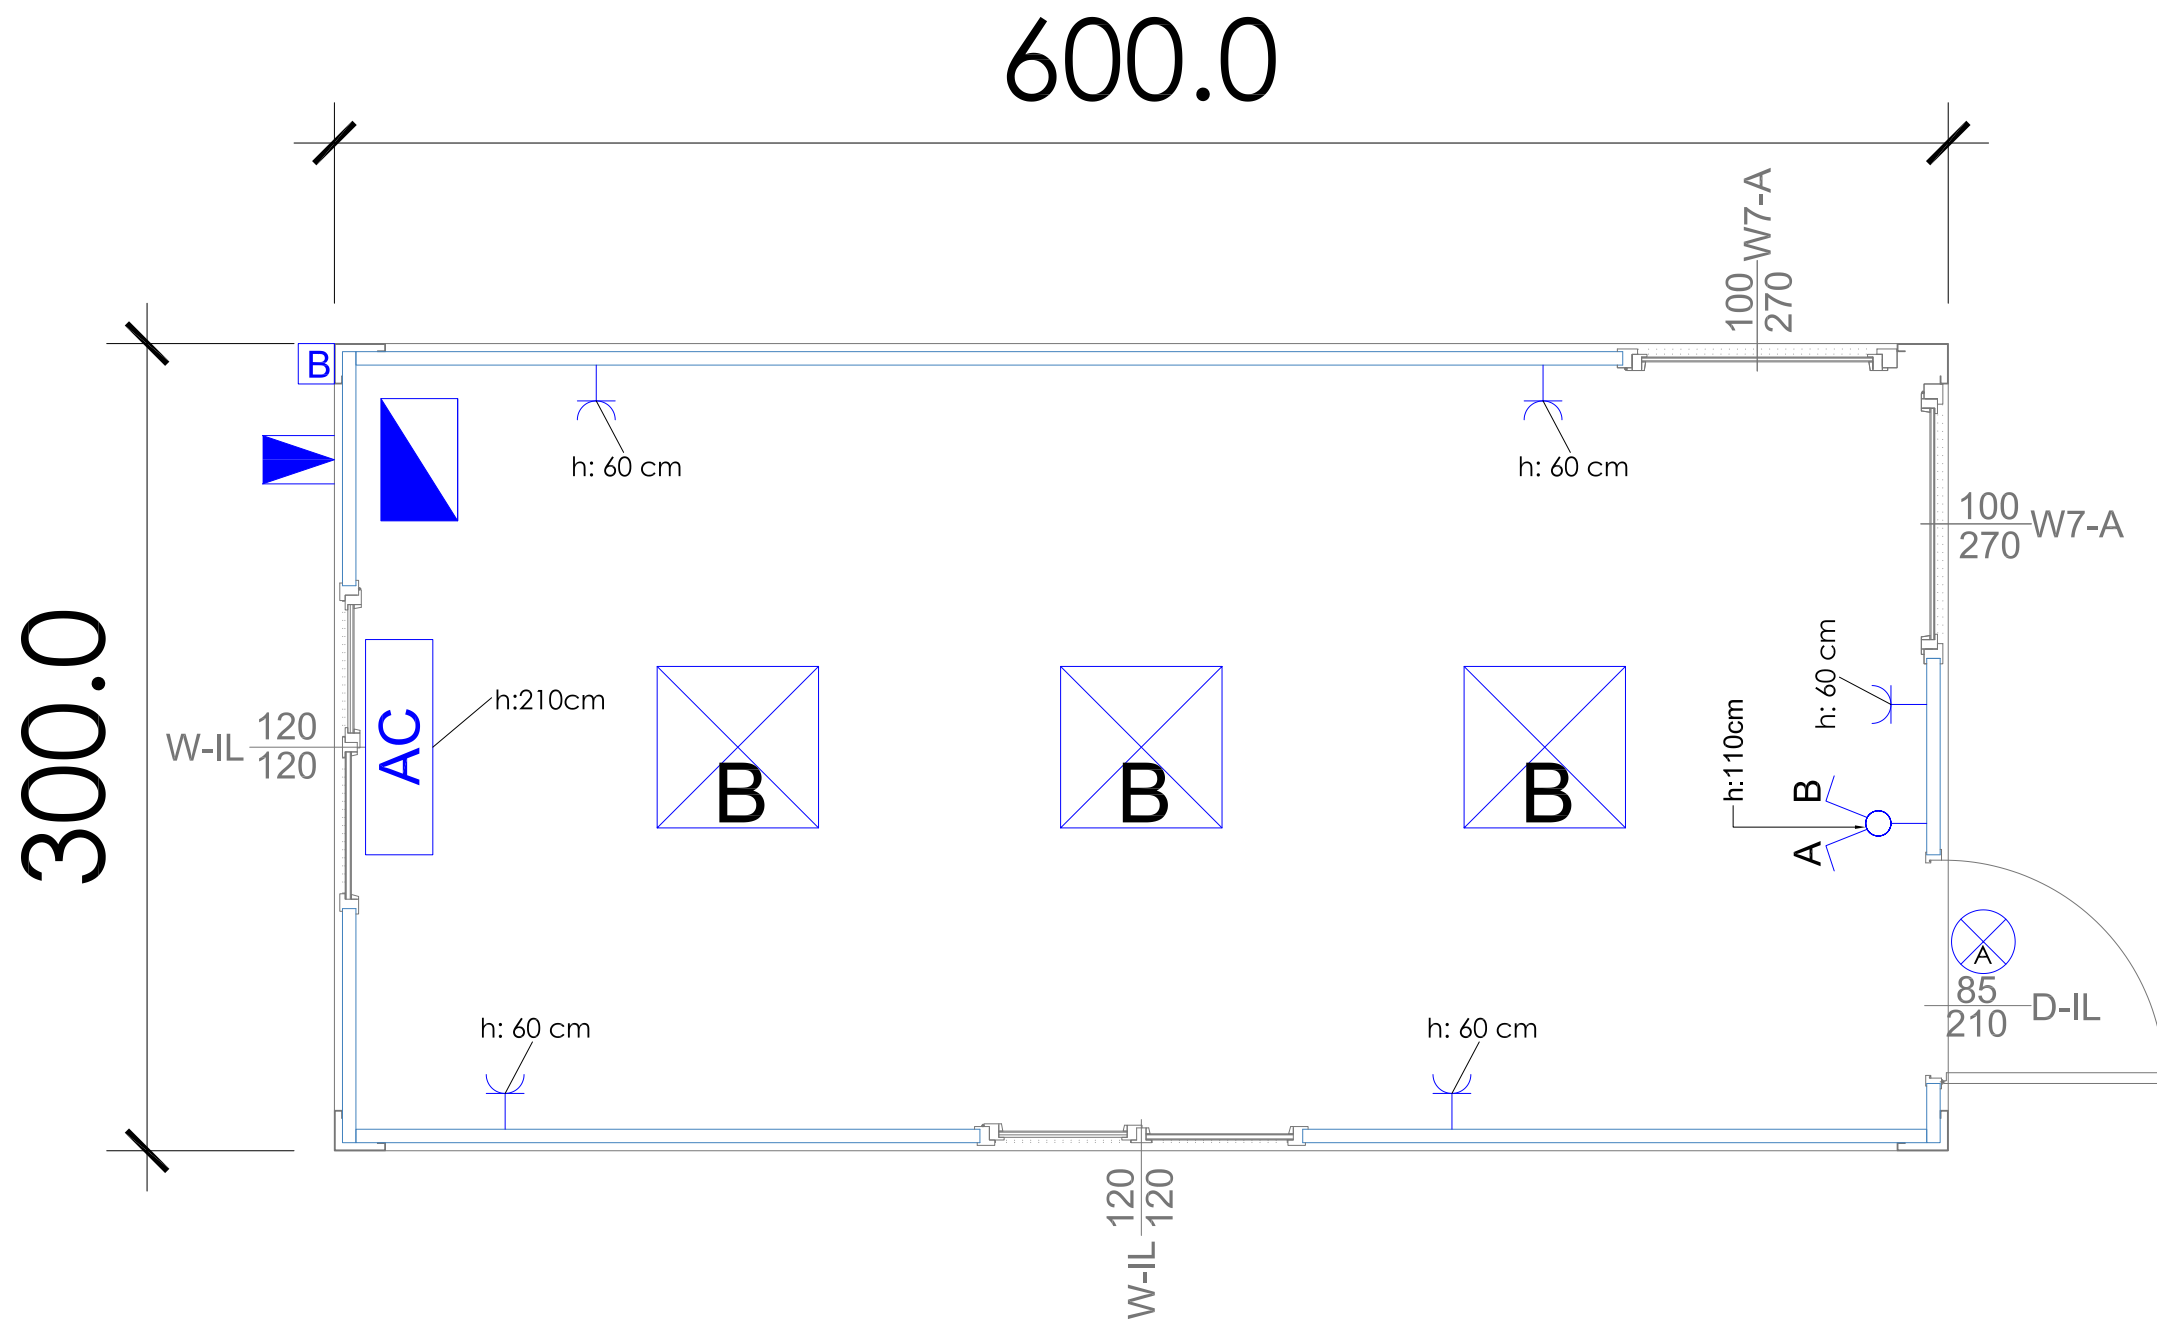

ELECTRICAL LEGEND

	FUSE BOX
	ELECTRICAL INLET
	SOCKET
	DOUBLE SWITCH
	60X60 LIGHTING FIXTURES
	AIR CONDITIONER

אאוטדור מודולר
פתרונות מתקדמים לבניה מודולרית

Kibbutz Mishmarot 37840 Doar Na Menashe Israel
Tel: 04-6277786
www.con-modular.co.il

client:

-

project:

TYPE B

18.0 m²




revision:

no	description	date
1.	-	-
2.	-	-
3.	-	-

drawn by: -

date: 26.12.2019

all dimensions are in centimeters

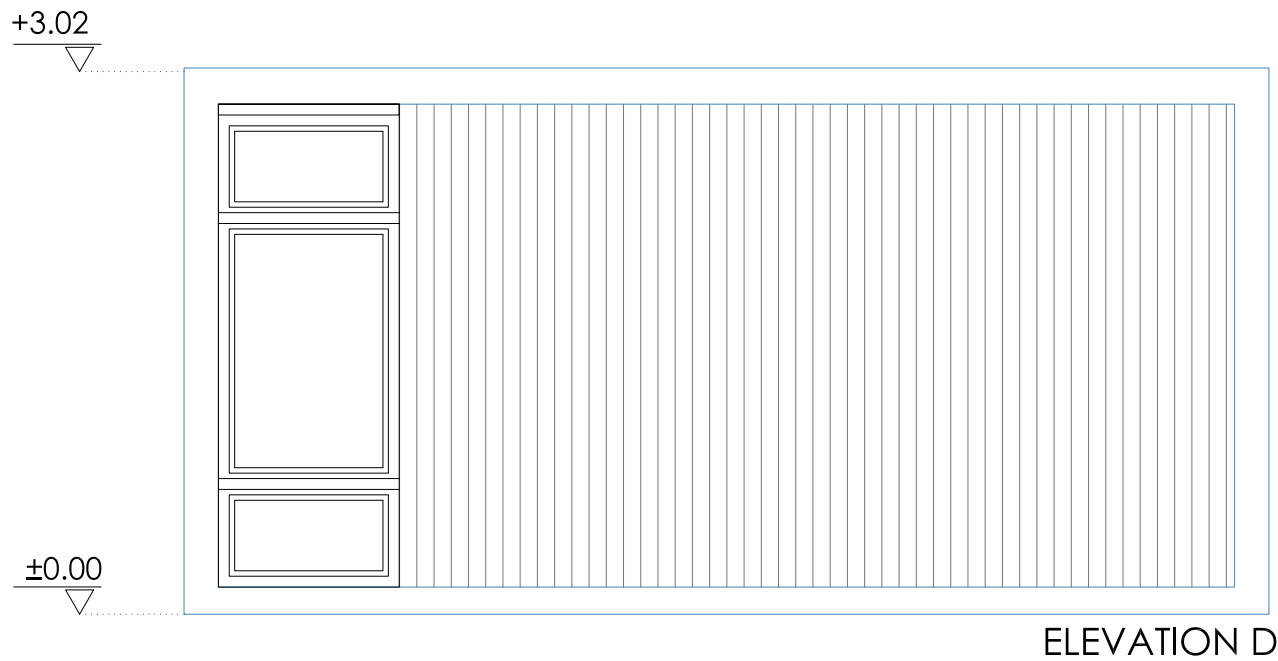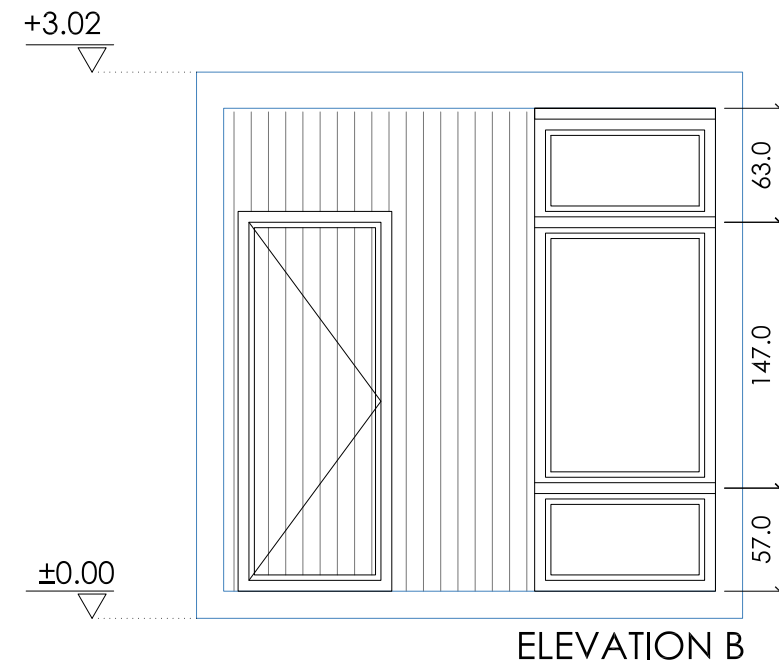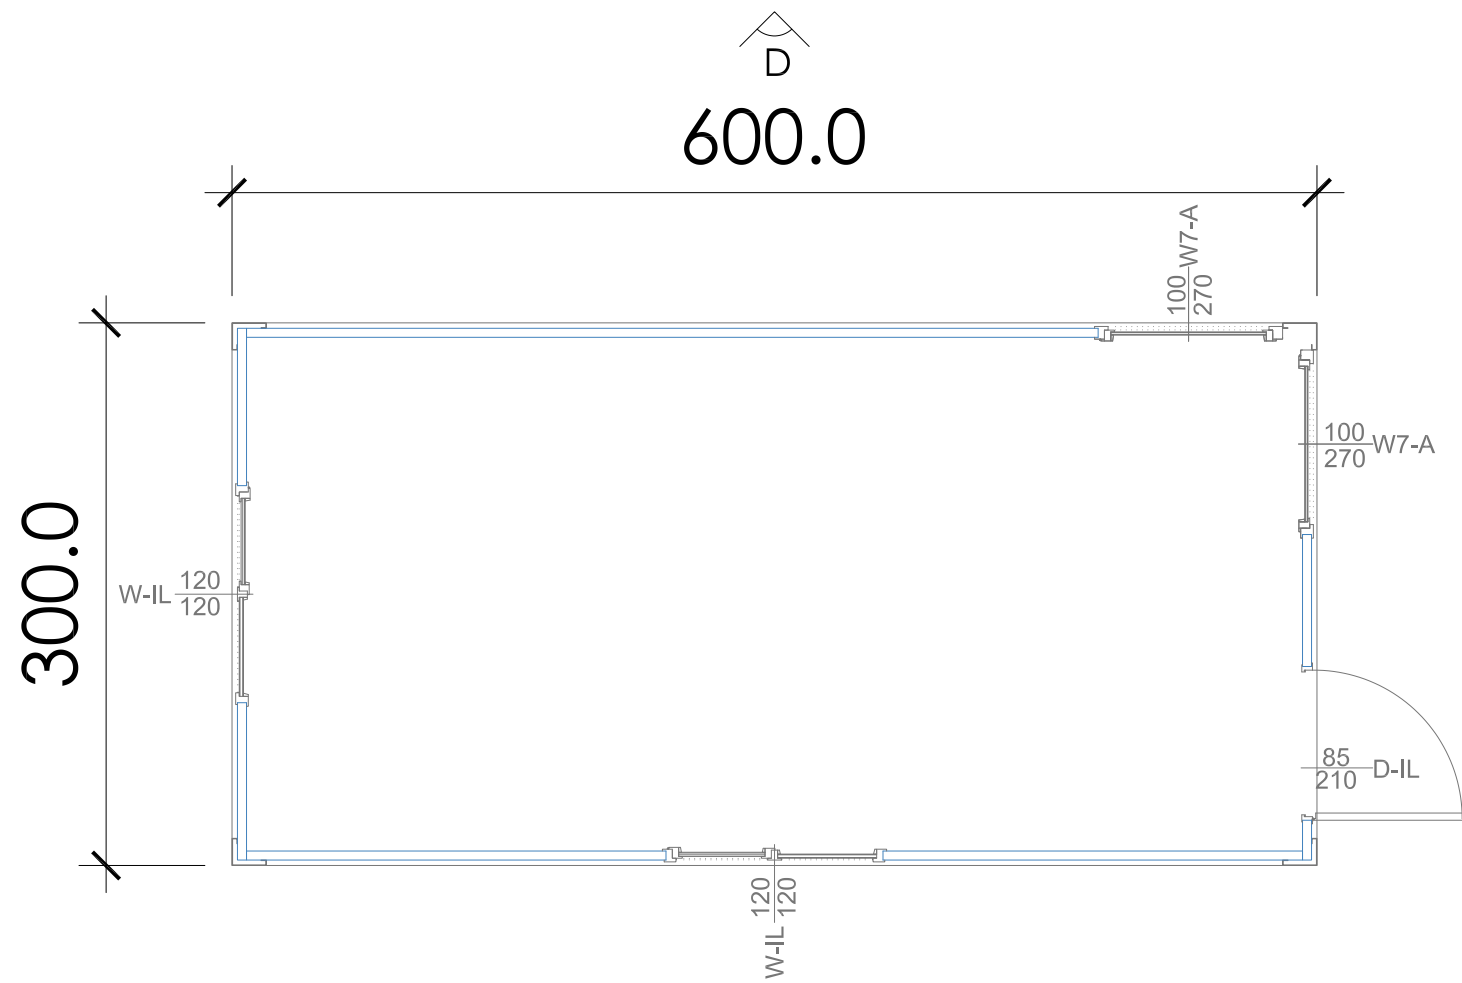

אונטדור מודולר
פתרונות מתקדמים לבניה מודולרית

Kibbutz Mishmarot 37840 Doar Na Menashe Israel
Tel: 04-6277786
www.con-modular.co.il

client:

-

project:

TYPE B 18.0 m²

revision:

no	description	date
1.	-	-
2.	-	-
3.	-	-

drawn by: -

date: 26.12.2019

all dimensions are in centimeters